

REV.	DATE	APPROV.	STATUS	DESCRIPTION
1				
2				
3				
4				
5				
6				
7				
8				
9				
10				


Project: NORTH CAROLINA STATE UNIVERSITY  
CLASSTECH STANDARDS

Drawing Title: SINGLE LINE DIAGRAMS  
AUDIO, VIDEO, CONTROL, NETWORK

Scale: NONE  
Date: 2017-2018  
Drawn by: BRENNAN WATSON  
Checked by:

Project Number:

Drawing # AV-401

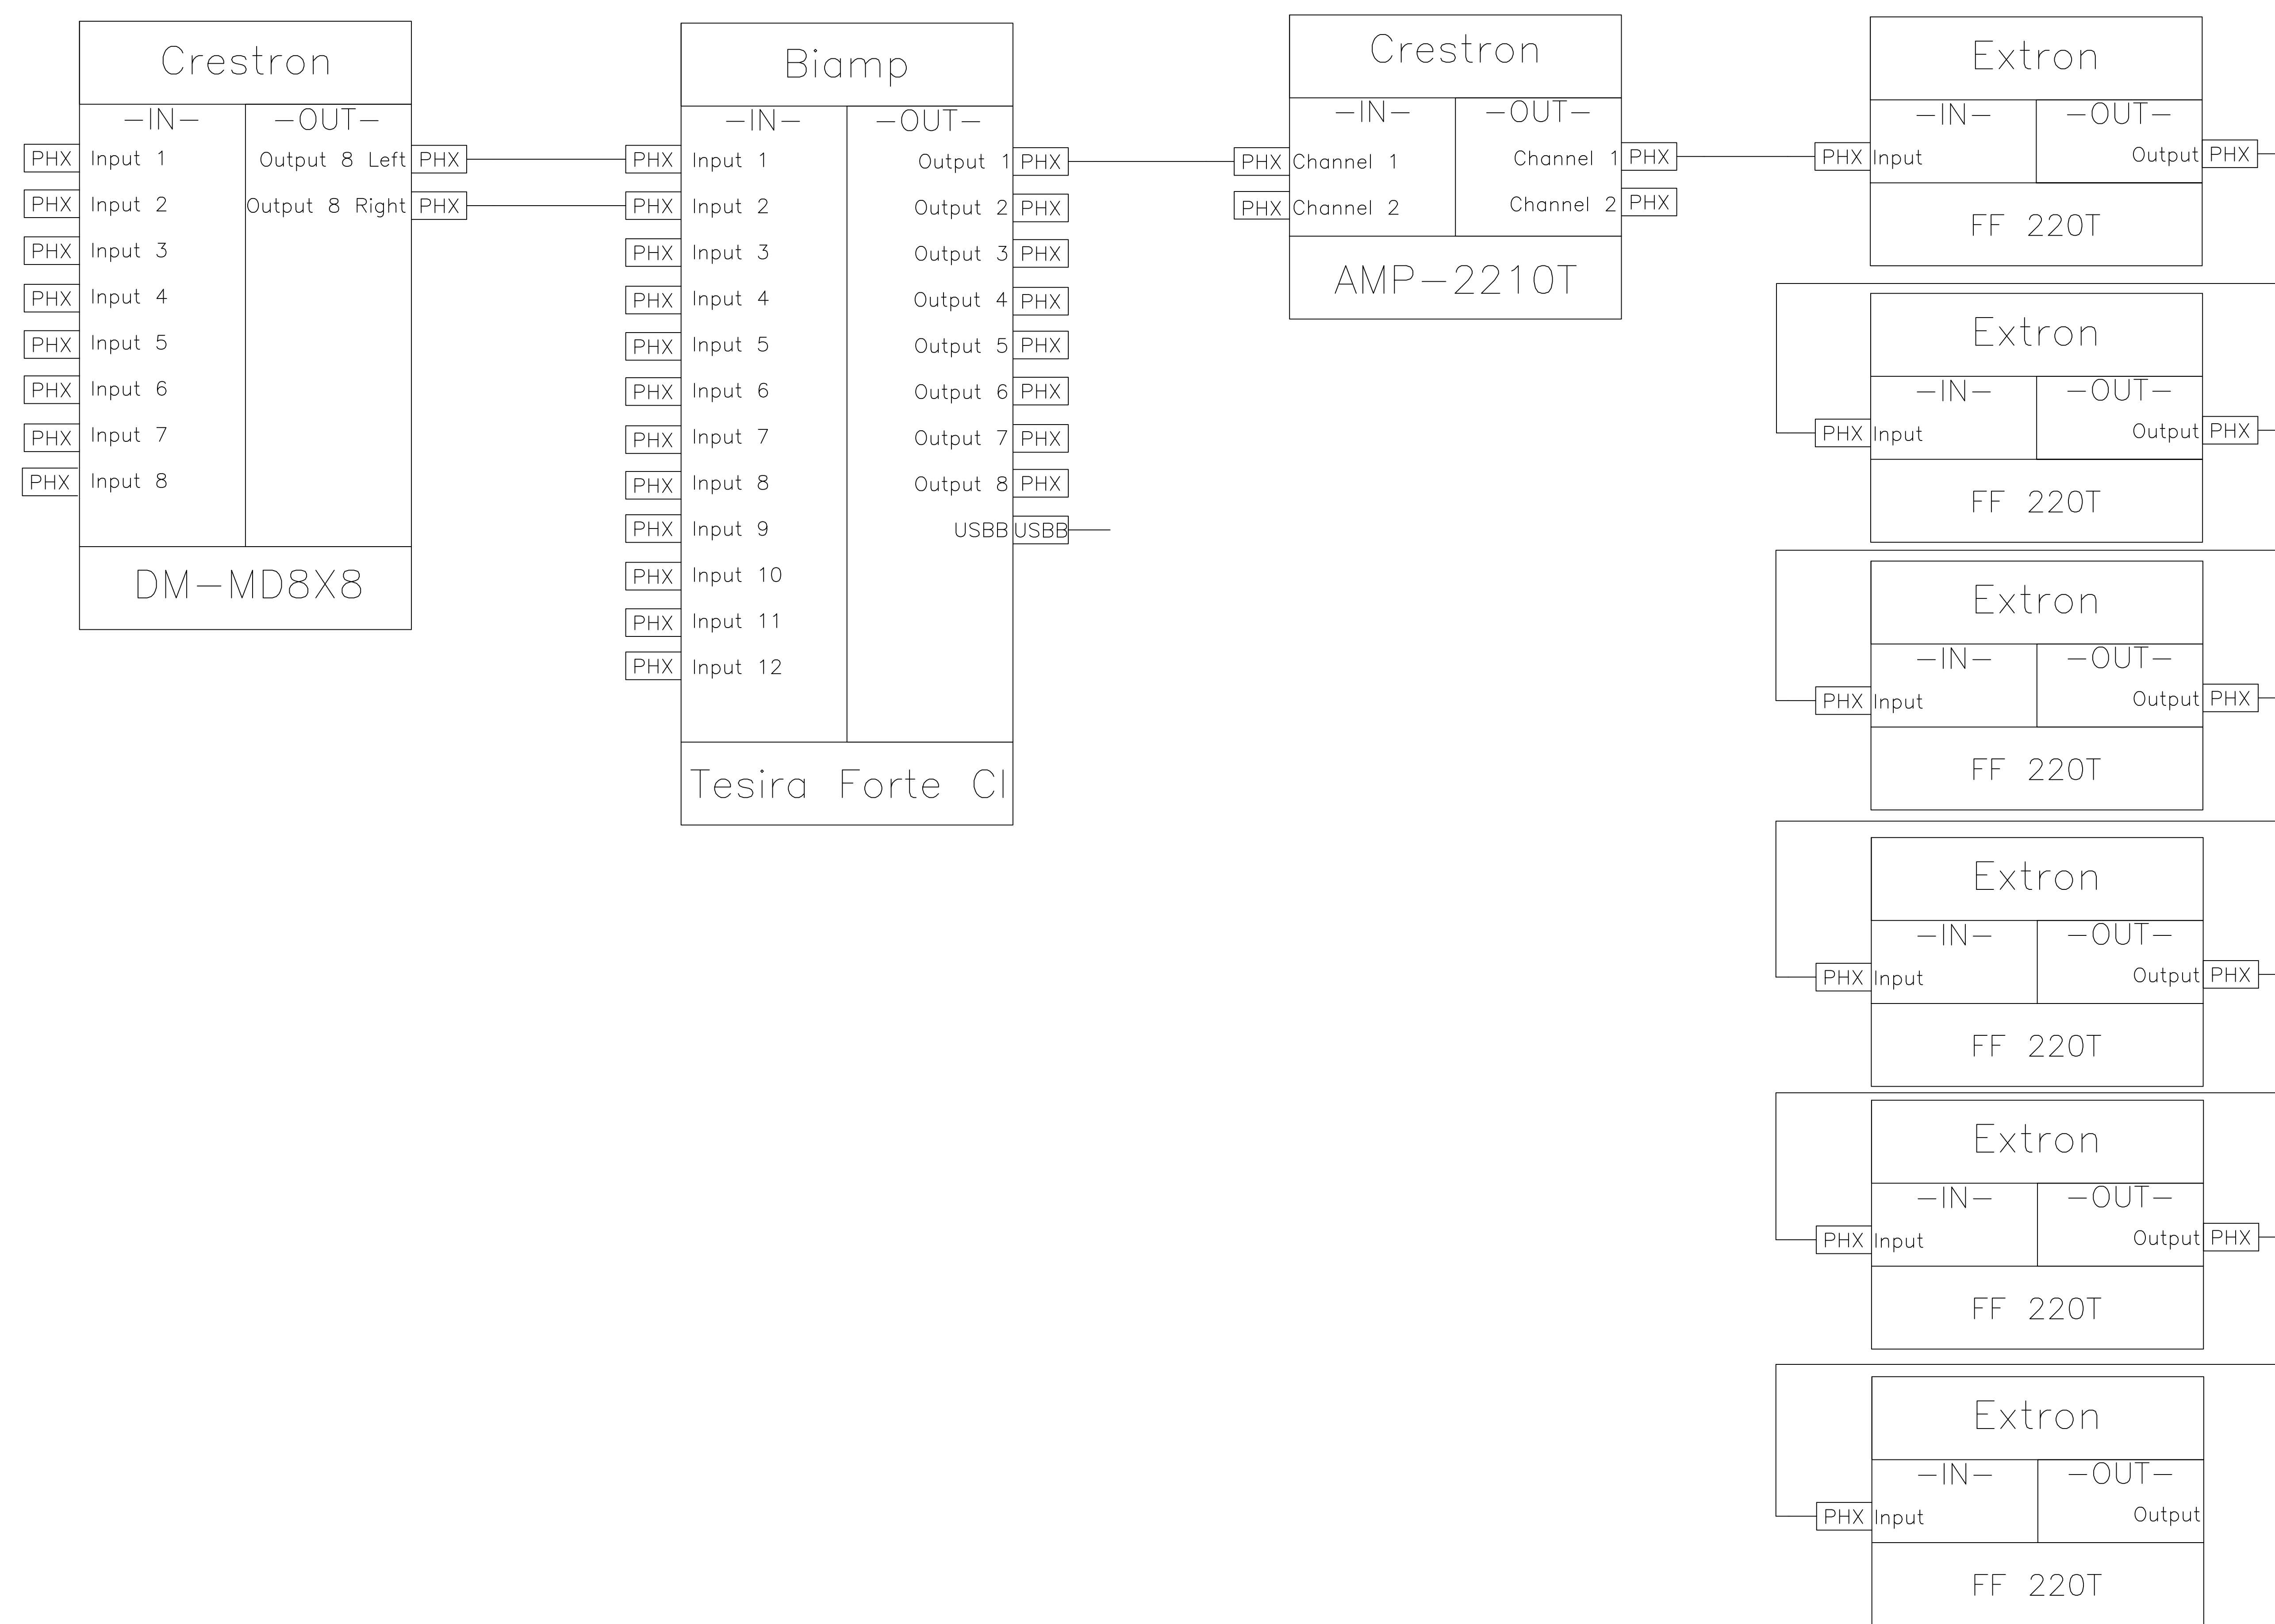

1 AUDIOVISUAL AUDIO FLOW  
402 NO SCALE

REV.	DATE	APPROV.	STATUS	DESCRIPTION
1				
2				
3				
4				
5				
6				
7				
8				
9				
10				

















Project: NORTH CAROLINA STATE UNIVERSITY  
CLASSTECH STANDARDS

Drawing Title: SINGLE LINE DIAGRAMS  
AUDIO, VIDEO, CONTROL, NETWORK

Scale: NONE  
Date: 2017-2018  
Drawn by: BRENNAN WATSON  
Checked by:

Project Number:

Drawing # AV-402

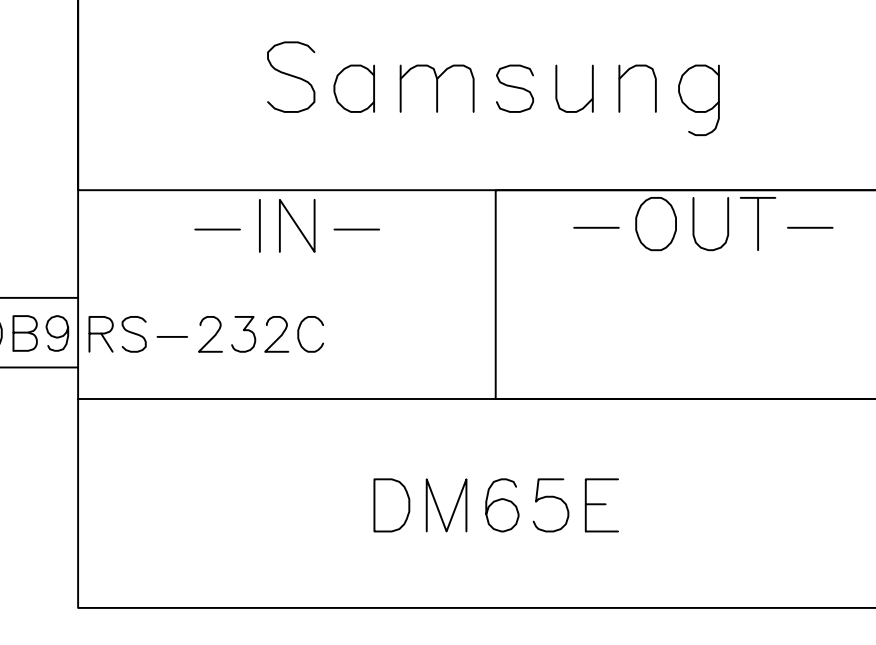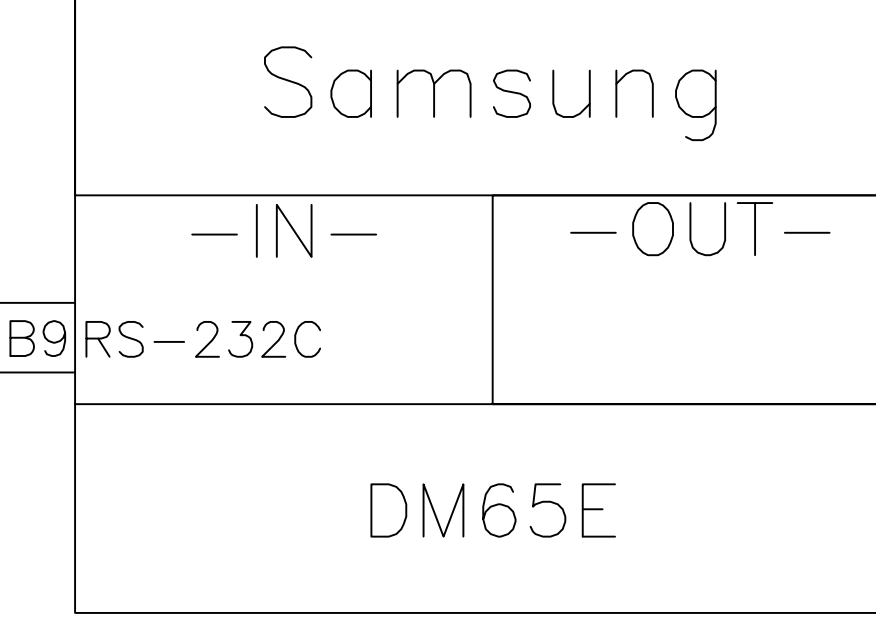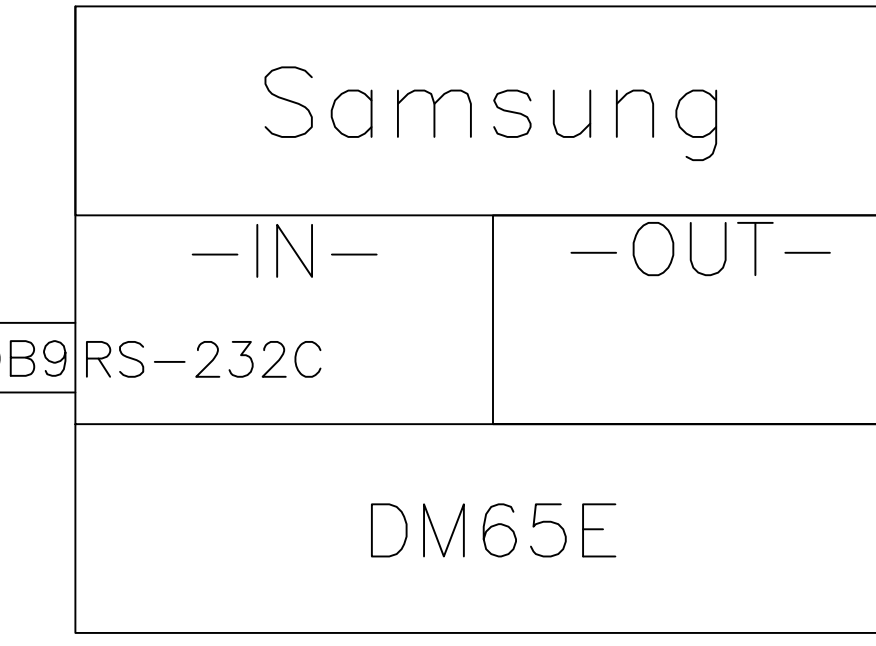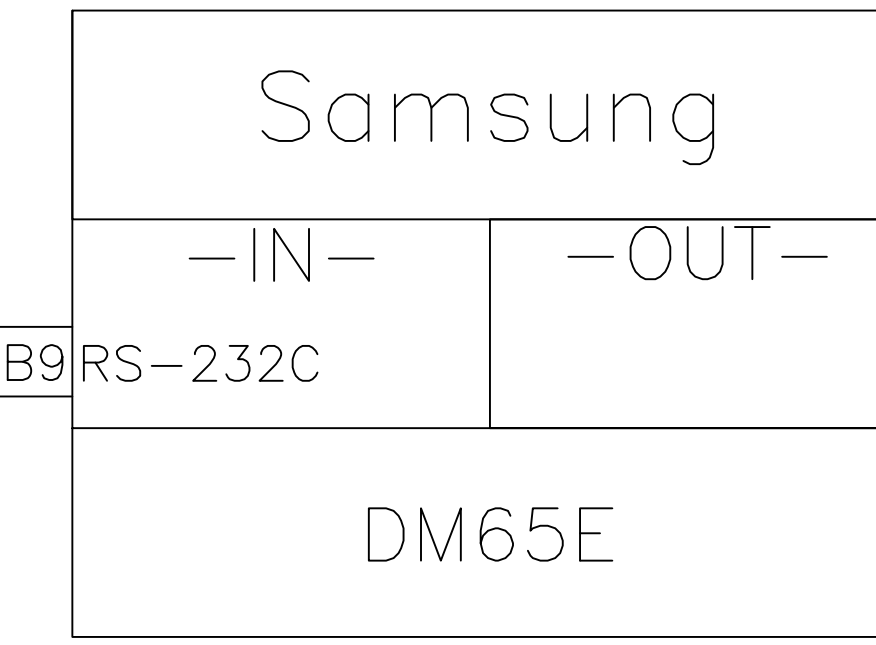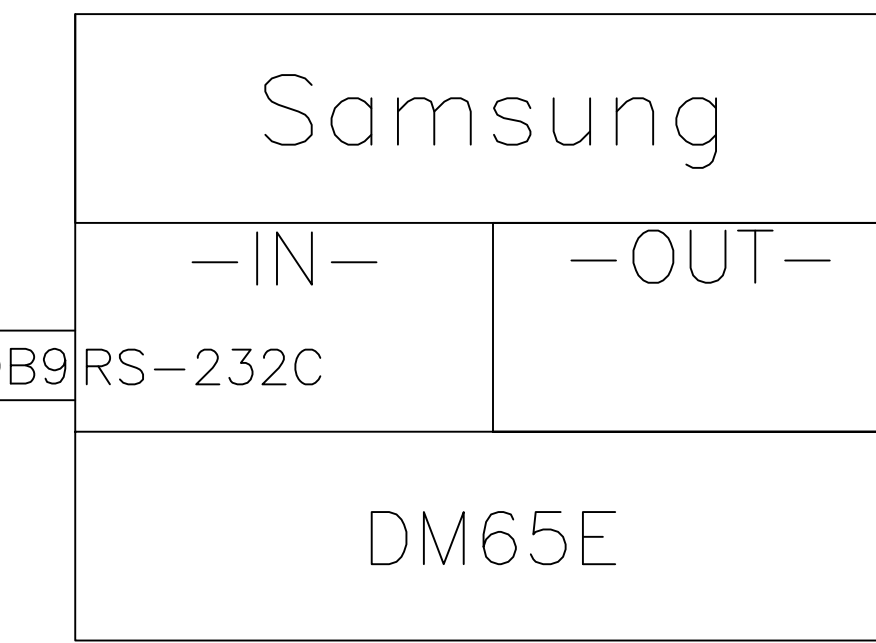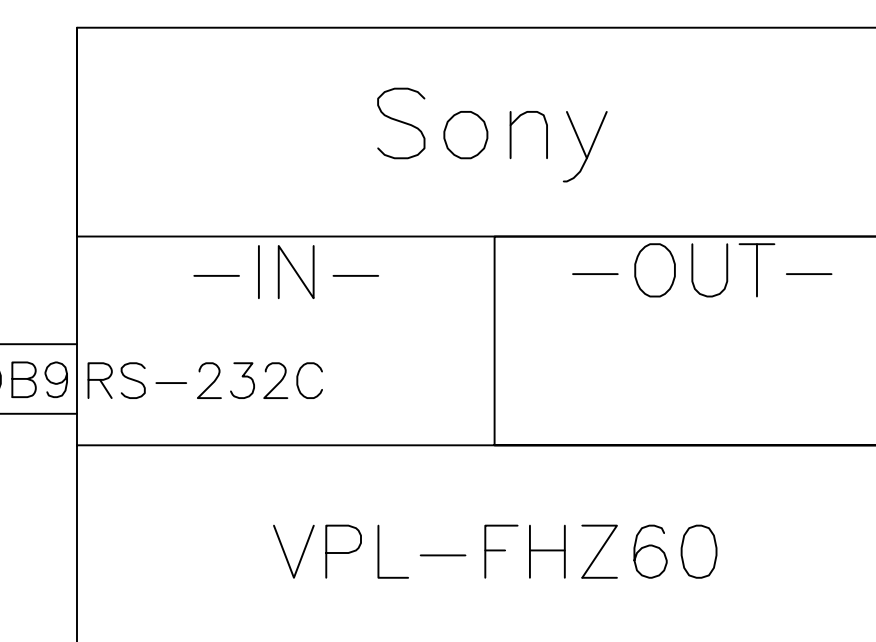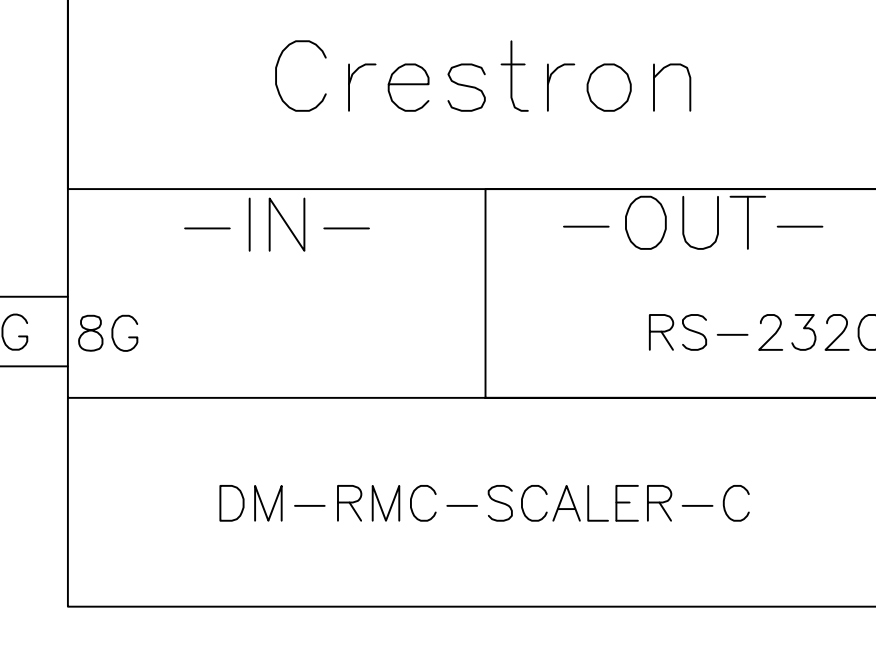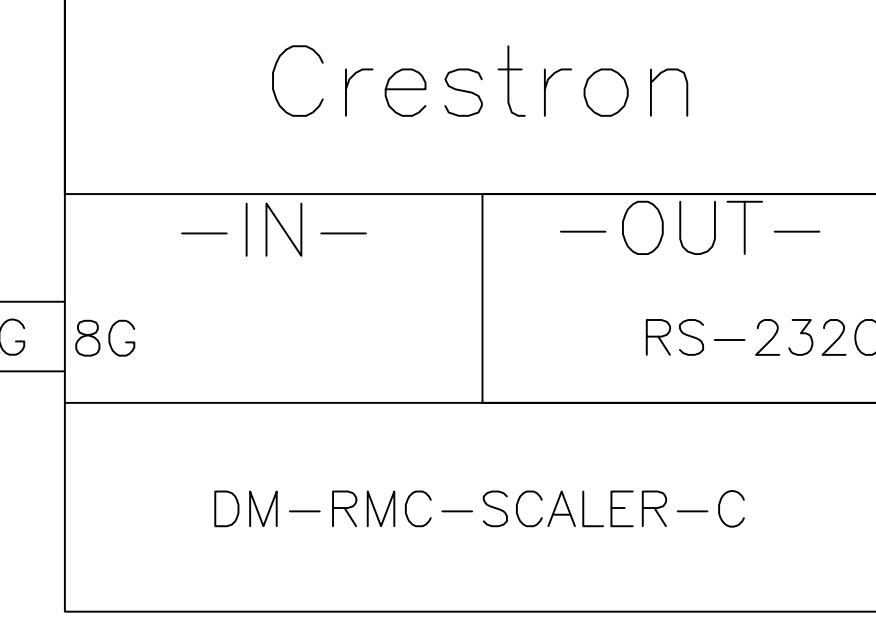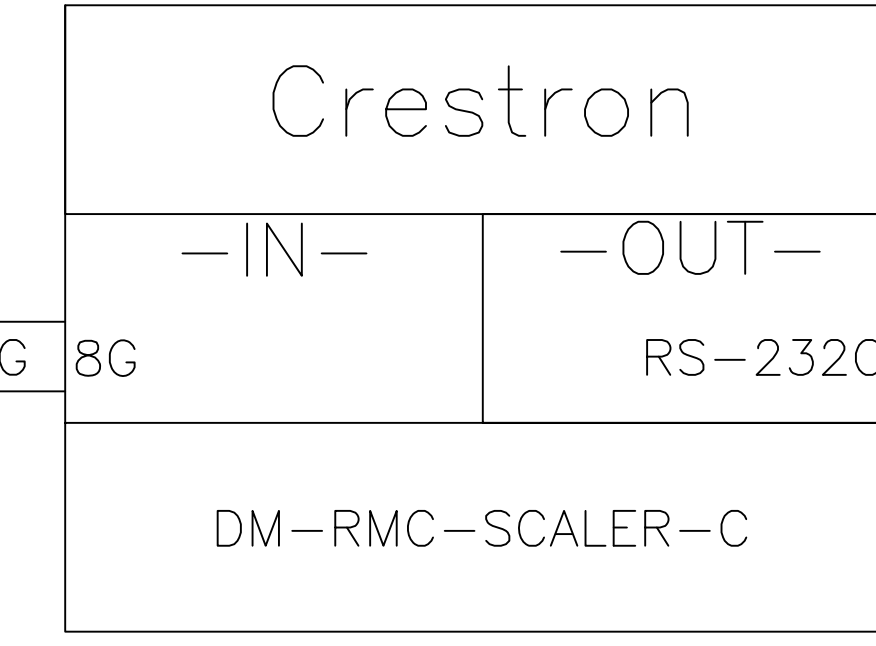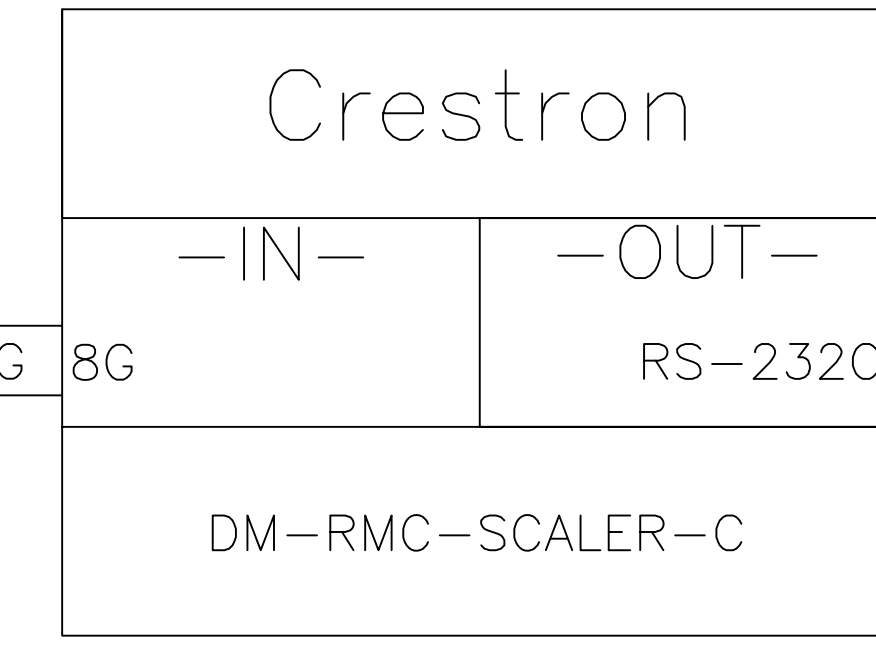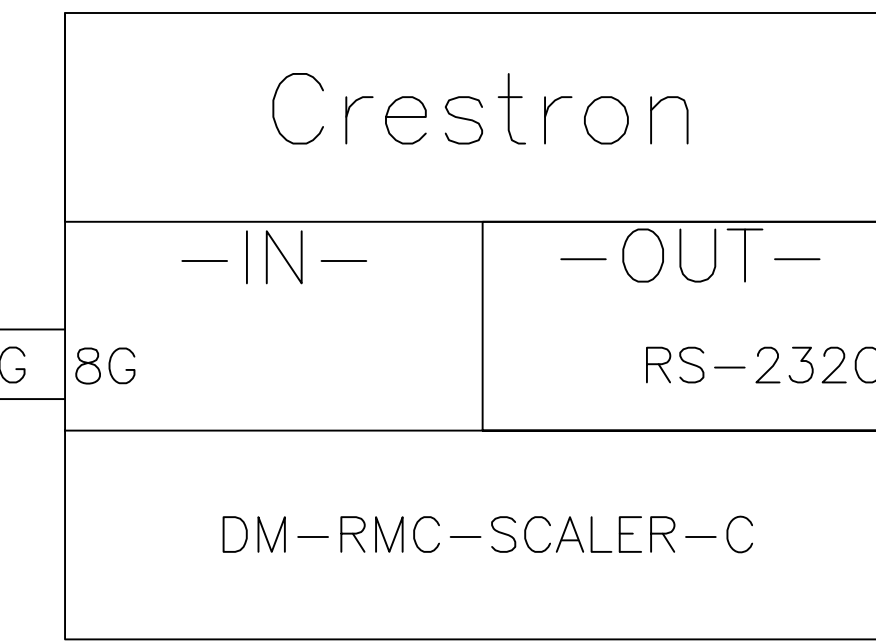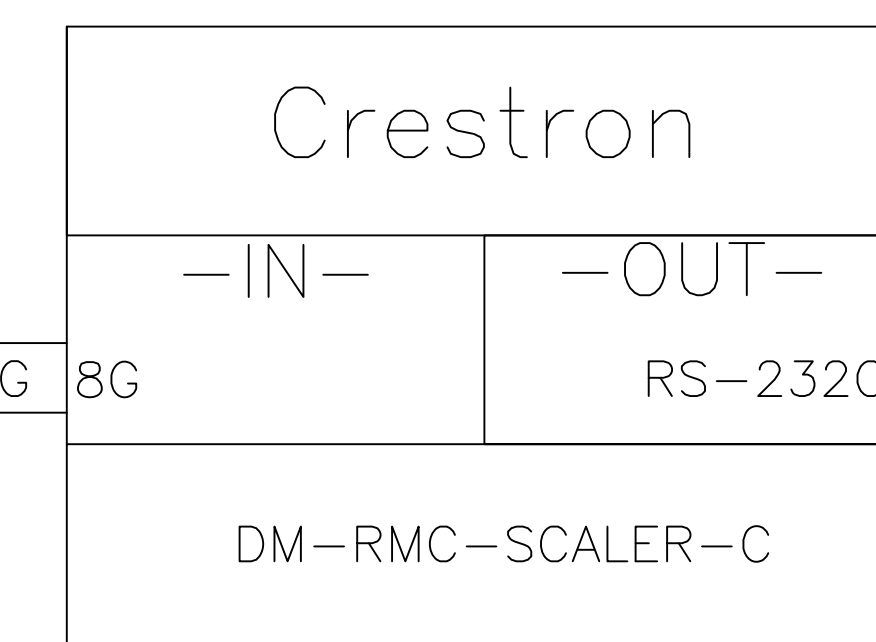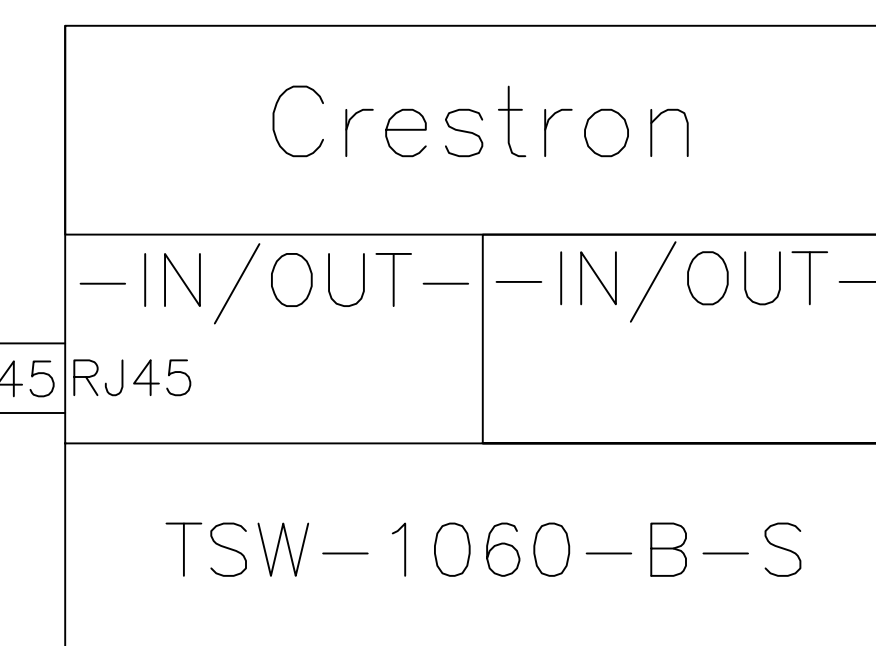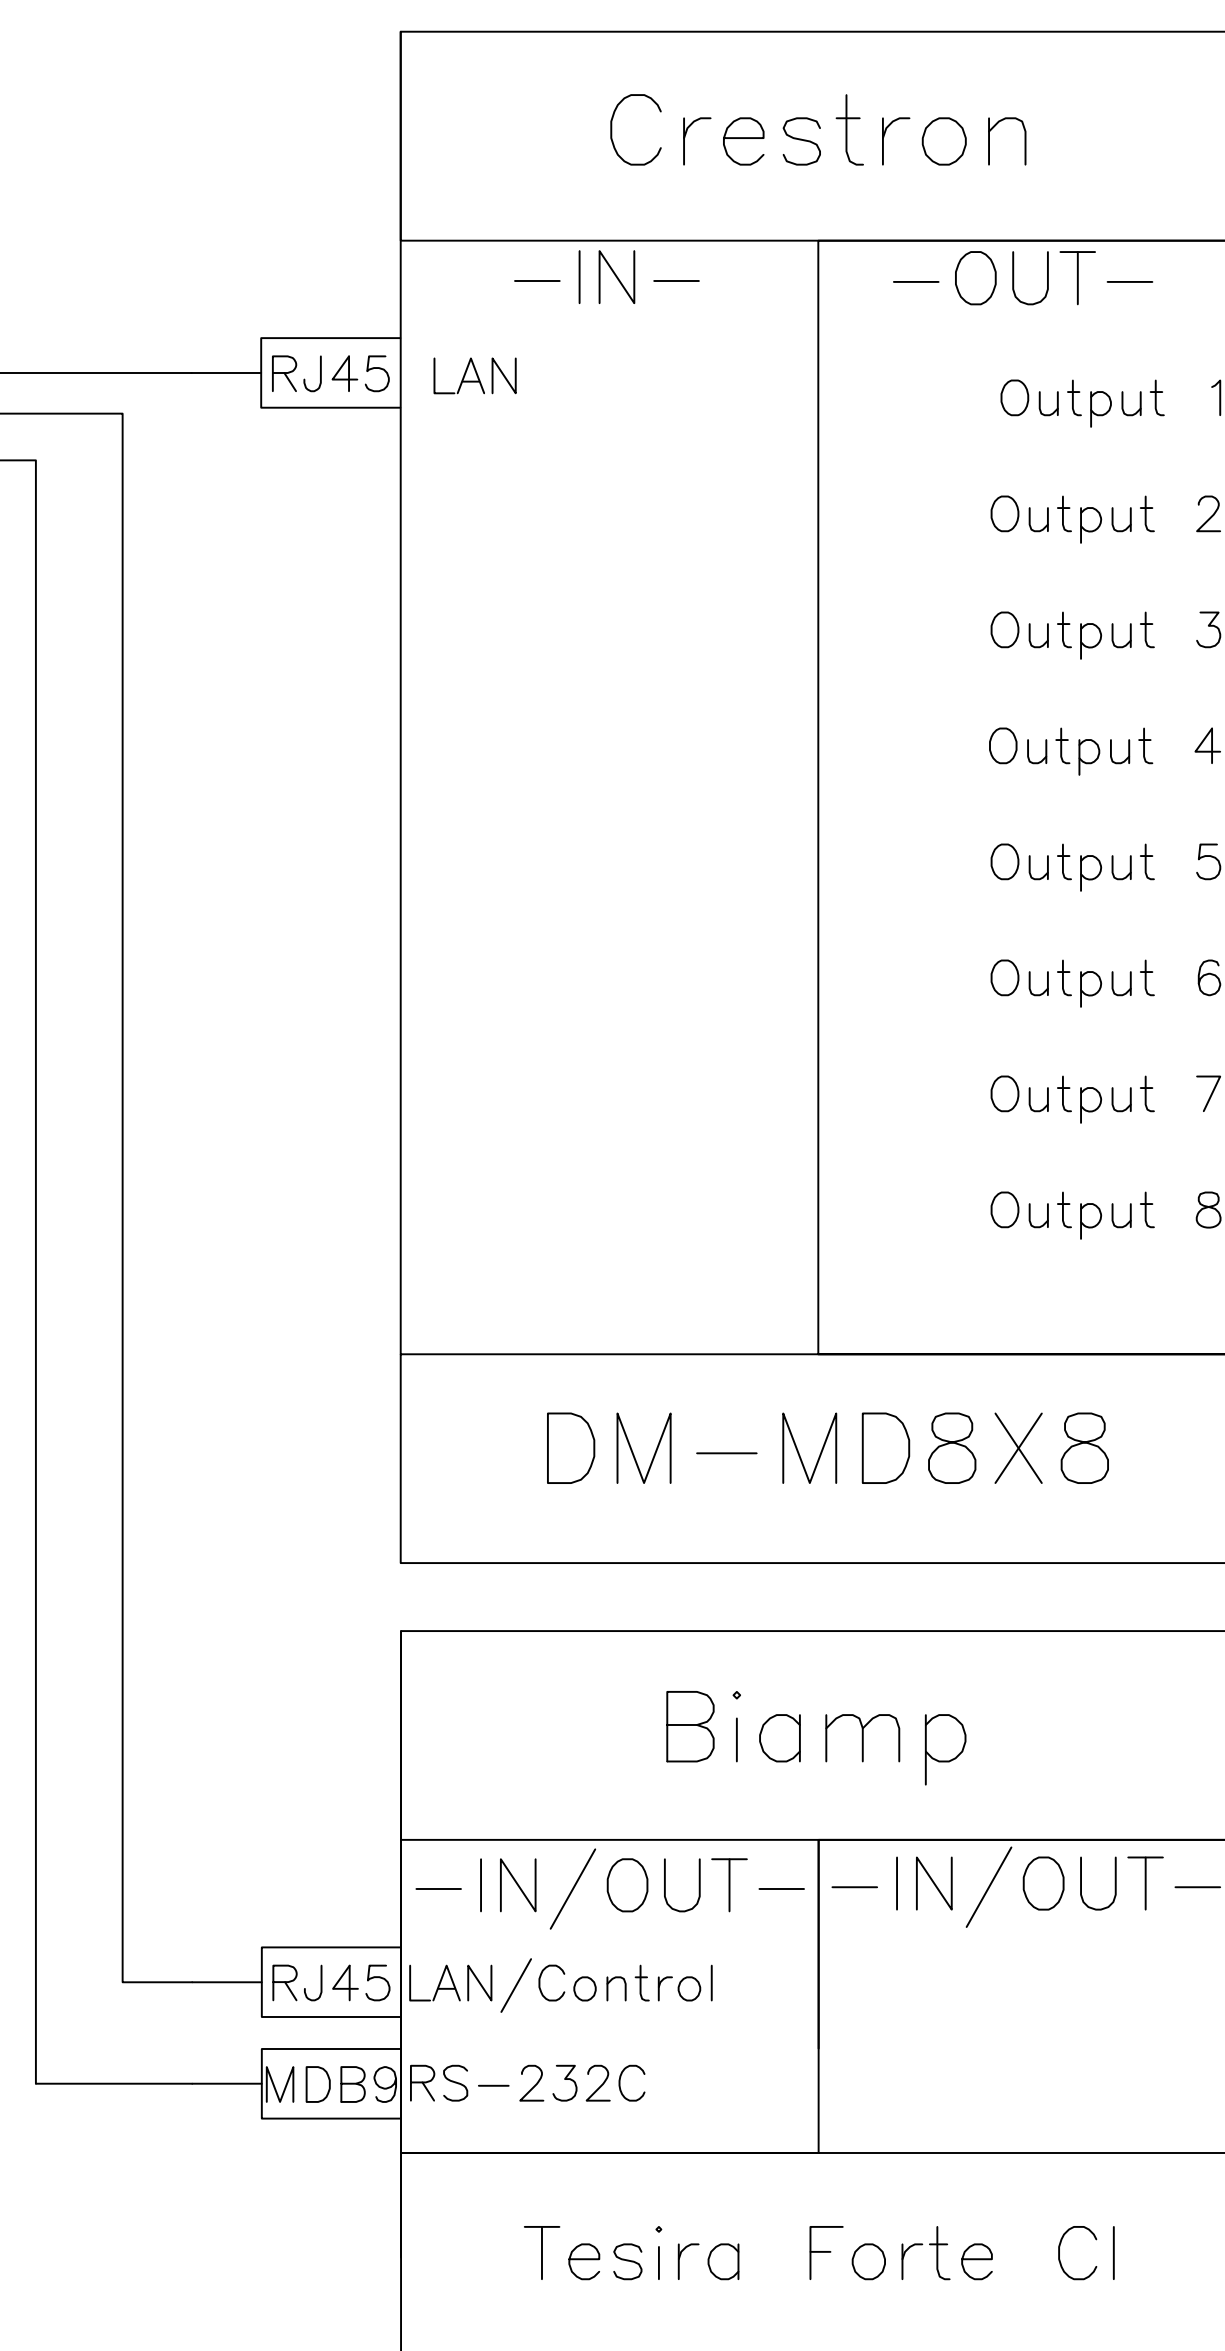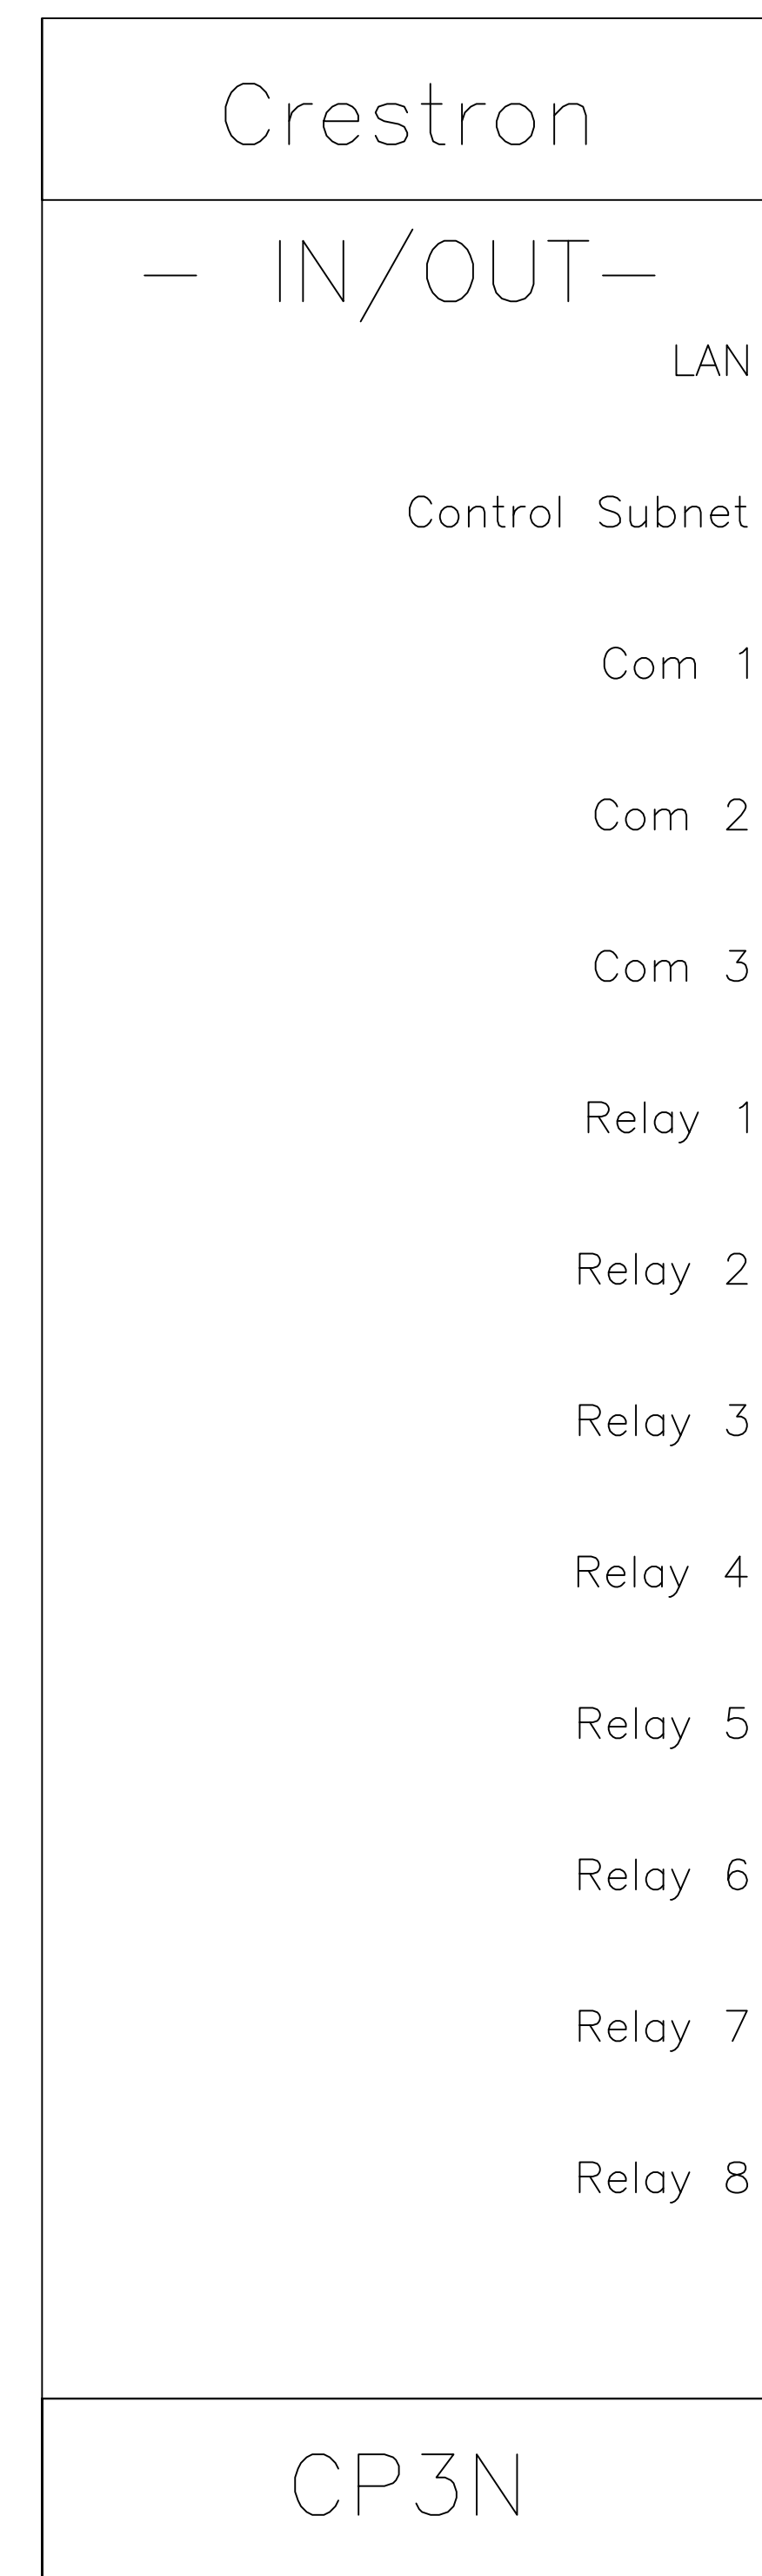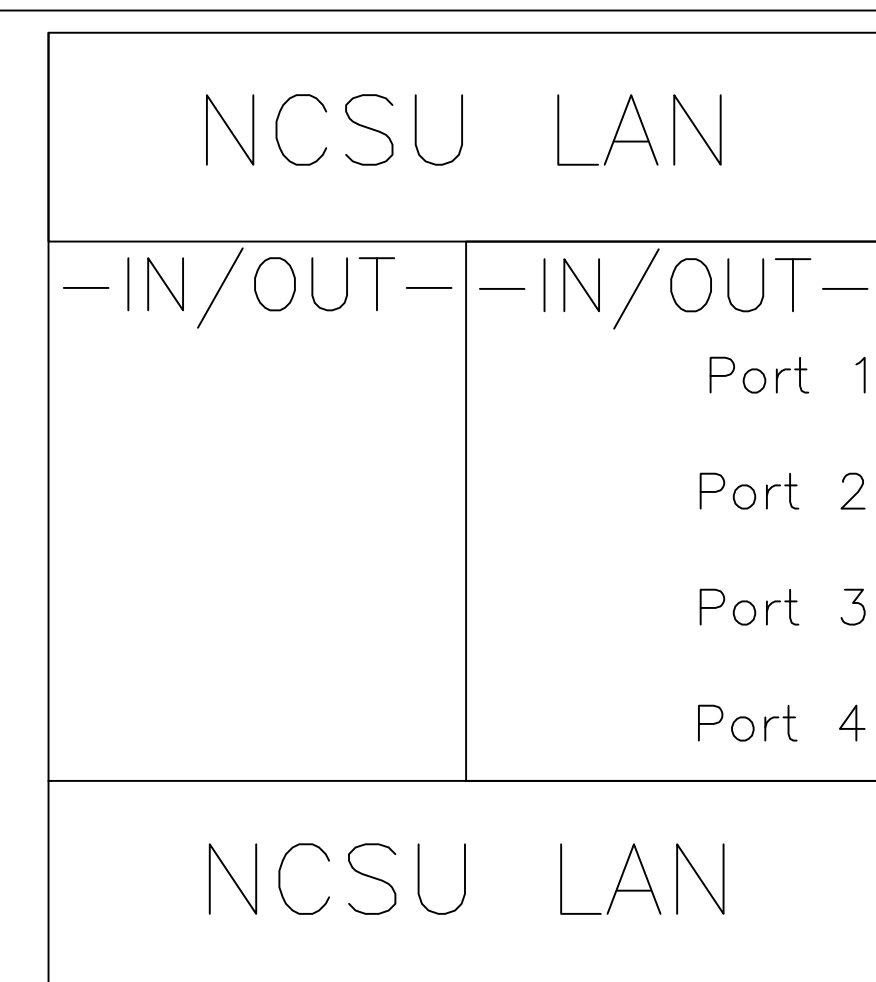

1 AUDIOVISUAL CONTROL FLOW  
406 NO SCALE

REV.	DATE	APPROV.	STATUS	DESCRIPTION
1				
2				
3				
4				
5				
6				
7				
8				
9				
10				

Project: NORTH CAROLINA STATE UNIVERSITY  
Drawing Title: CLASSSTECH STANDARDS  
SINGLE LINE DIAGRAMS  
AUDIO, VIDEO, CONTROL, NETWORK

Scale: NONE  
Date: 2017-2018  
Drawn by: BRENNAN WATSON  
Checked by:

Project Number:

Drawing # AV-403