

1 AUDIOVISUAL VIDEO FLOW
401 NO SCALE


REV.	DATE	APPROV.	STATUS	DESCRIPTION
1				
2				
3				
4				
5				
6				
7				
8				
9				
10				

Project: NORTH CAROLINA STATE UNIVERSITY
CLASSTECH STANDARD
Drawing Title: SINGLE LINE DIAGRAMS
AUDIO, VIDEO, CONTROL, NETWORK

Scale: NONE
Date: 2017-2018
Drawn by: BRENNAN WATSON
Checked by:

Project Number:

Drawing # AV-401

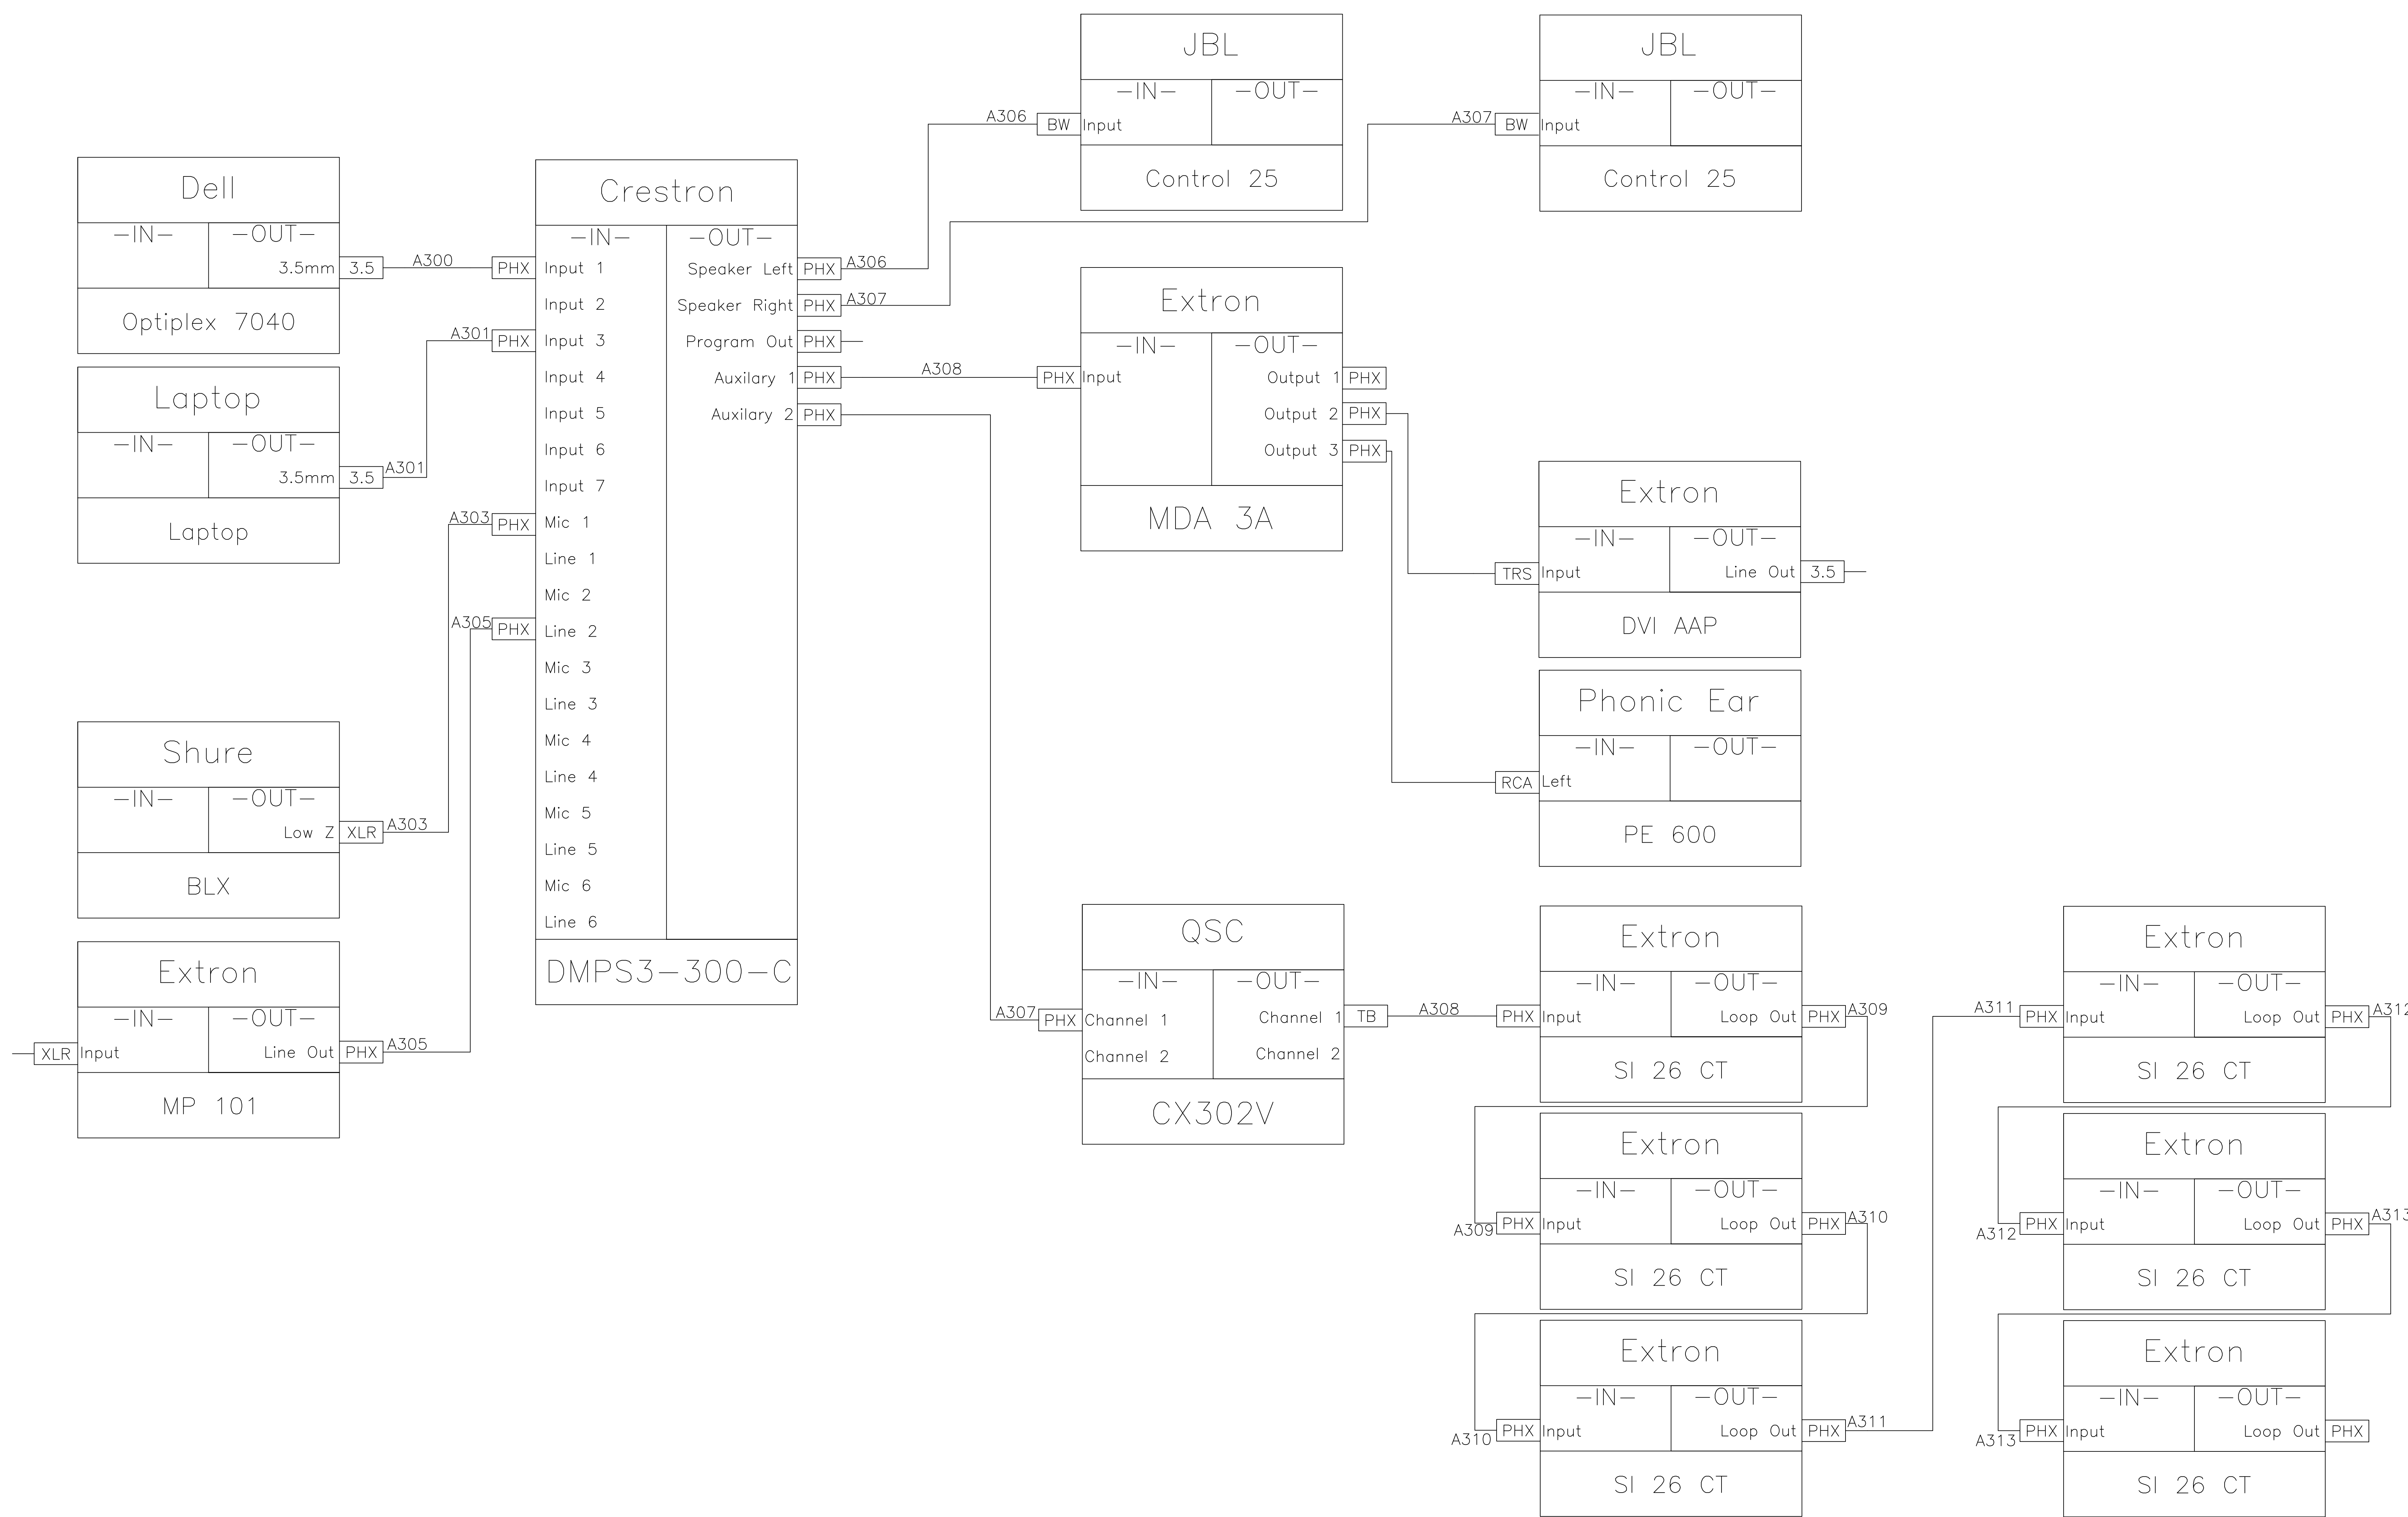

1 AUDIOVISUAL AUDIO FLOW
402 NO SCALE


REV.	DATE	APPROV.	STATUS	DESCRIPTION
1				
2				
3				
4				
5				
6				
7				
8				
9				
10				

NORTH CAROLINA STATE UNIVERSITY
CLASSTECH STANDARD
SINGLE LINE DIAGRAMS
AUDIO, VIDEO, CONTROL, NETWORK

Project: _____
Scale: NONE
Date: 2017-2018
Drawn by: BRENNAN WATSON
Checked by: _____

Project Number: _____

Drawing # AV-402

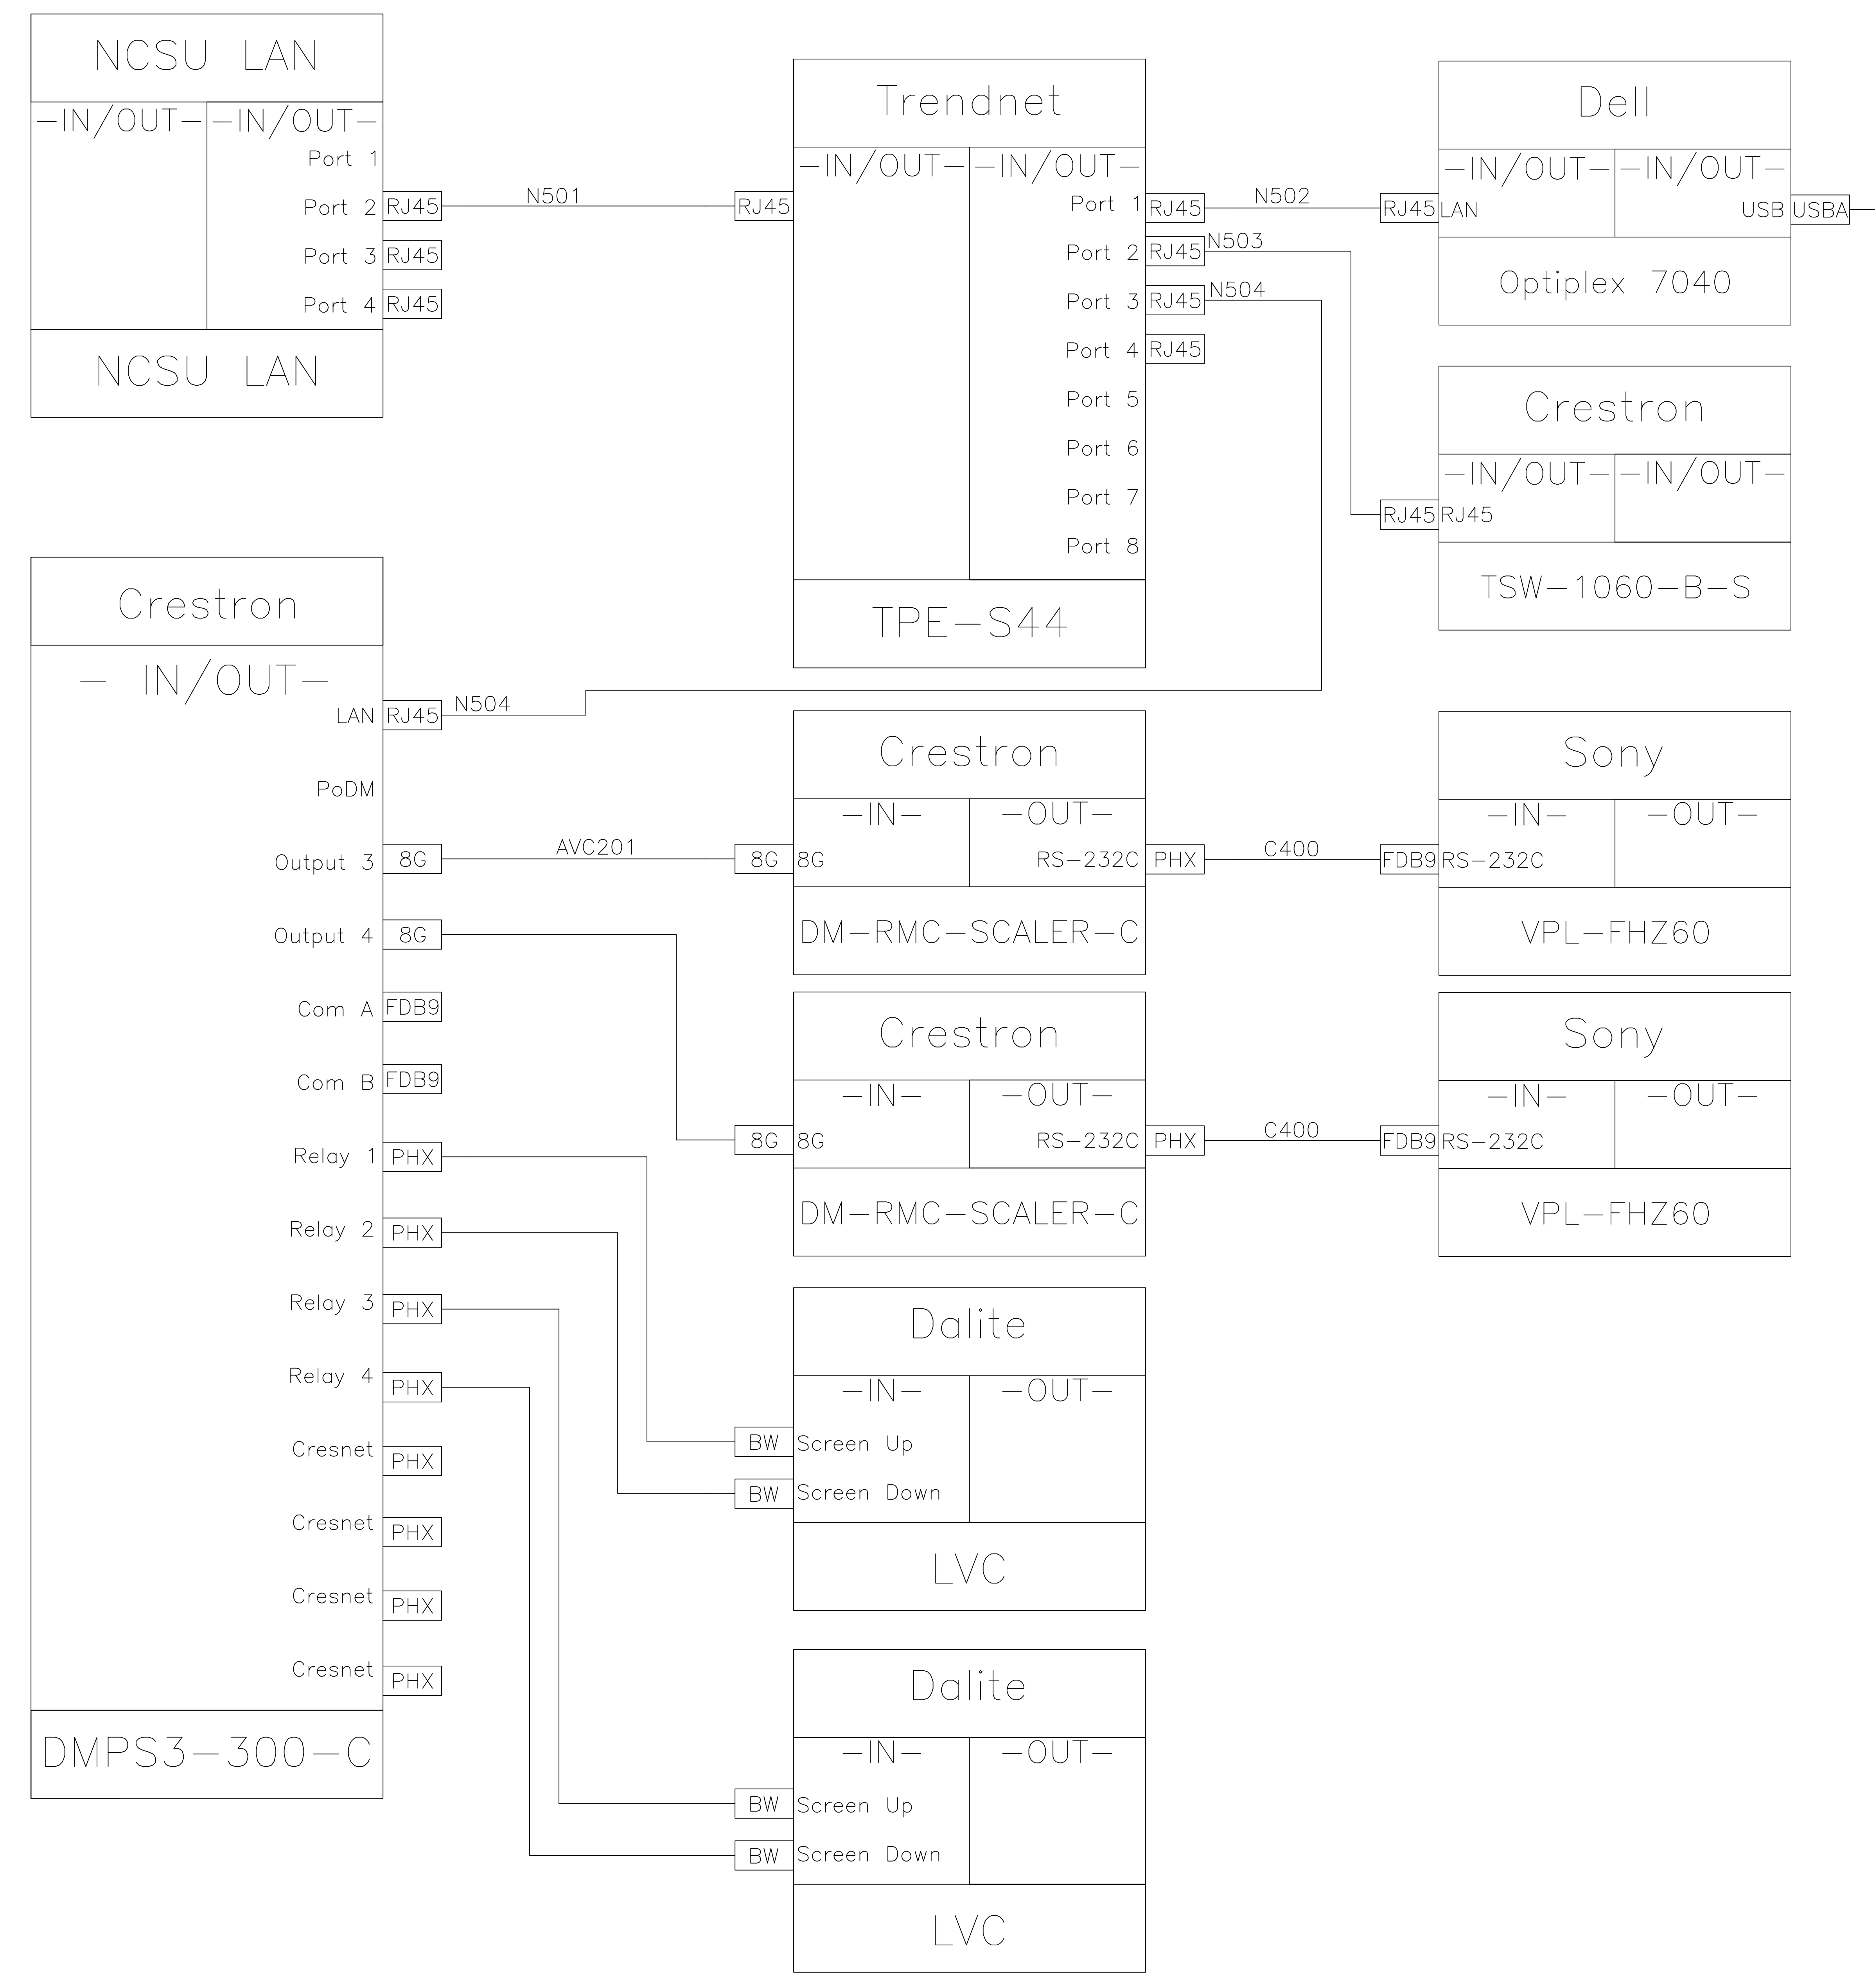

1 AUDIOVISUAL CONTROL FLOW
 403 NO SCALE

NORTH CAROLINA STATE UNIVERSITY
 CLASSTECH STANDARD
 SINGLE LINE DIAGRAMS
 AUDIO, VIDEO, CONTROL, NETWORK

Project: NORTH CAROLINA STATE UNIVERSITY
 Drawing Title: SINGLE LINE DIAGRAMS
 AUDIO, VIDEO, CONTROL, NETWORK
 Scale: NONE
 Date: 2017-2018
 Drawn by: BRENNAN WATSON
 Checked by:

Project Number:

Drawing # AV-403