

1 AUDIOVISUAL VIDEO FLOW
 401 NO SCALE


REV.	DATE	APPROV.	STATUS	DESCRIPTION
1				
2				
3				
4				
5				
6				
7				
8				
9				
10				

Project: NORTH CAROLINA STATE UNIVERSITY
 CLASSTECH STANDARD
 Drawing Title: SINGLE LINE DIAGRAMS
 AUDIO, VIDEO, CONTROL, NETWORK

Scale: NONE
 Date: 2017-2018
 Drawn by: BRENNAN WATSON
 Checked by:

Project Number:

Drawing #
 AV-401

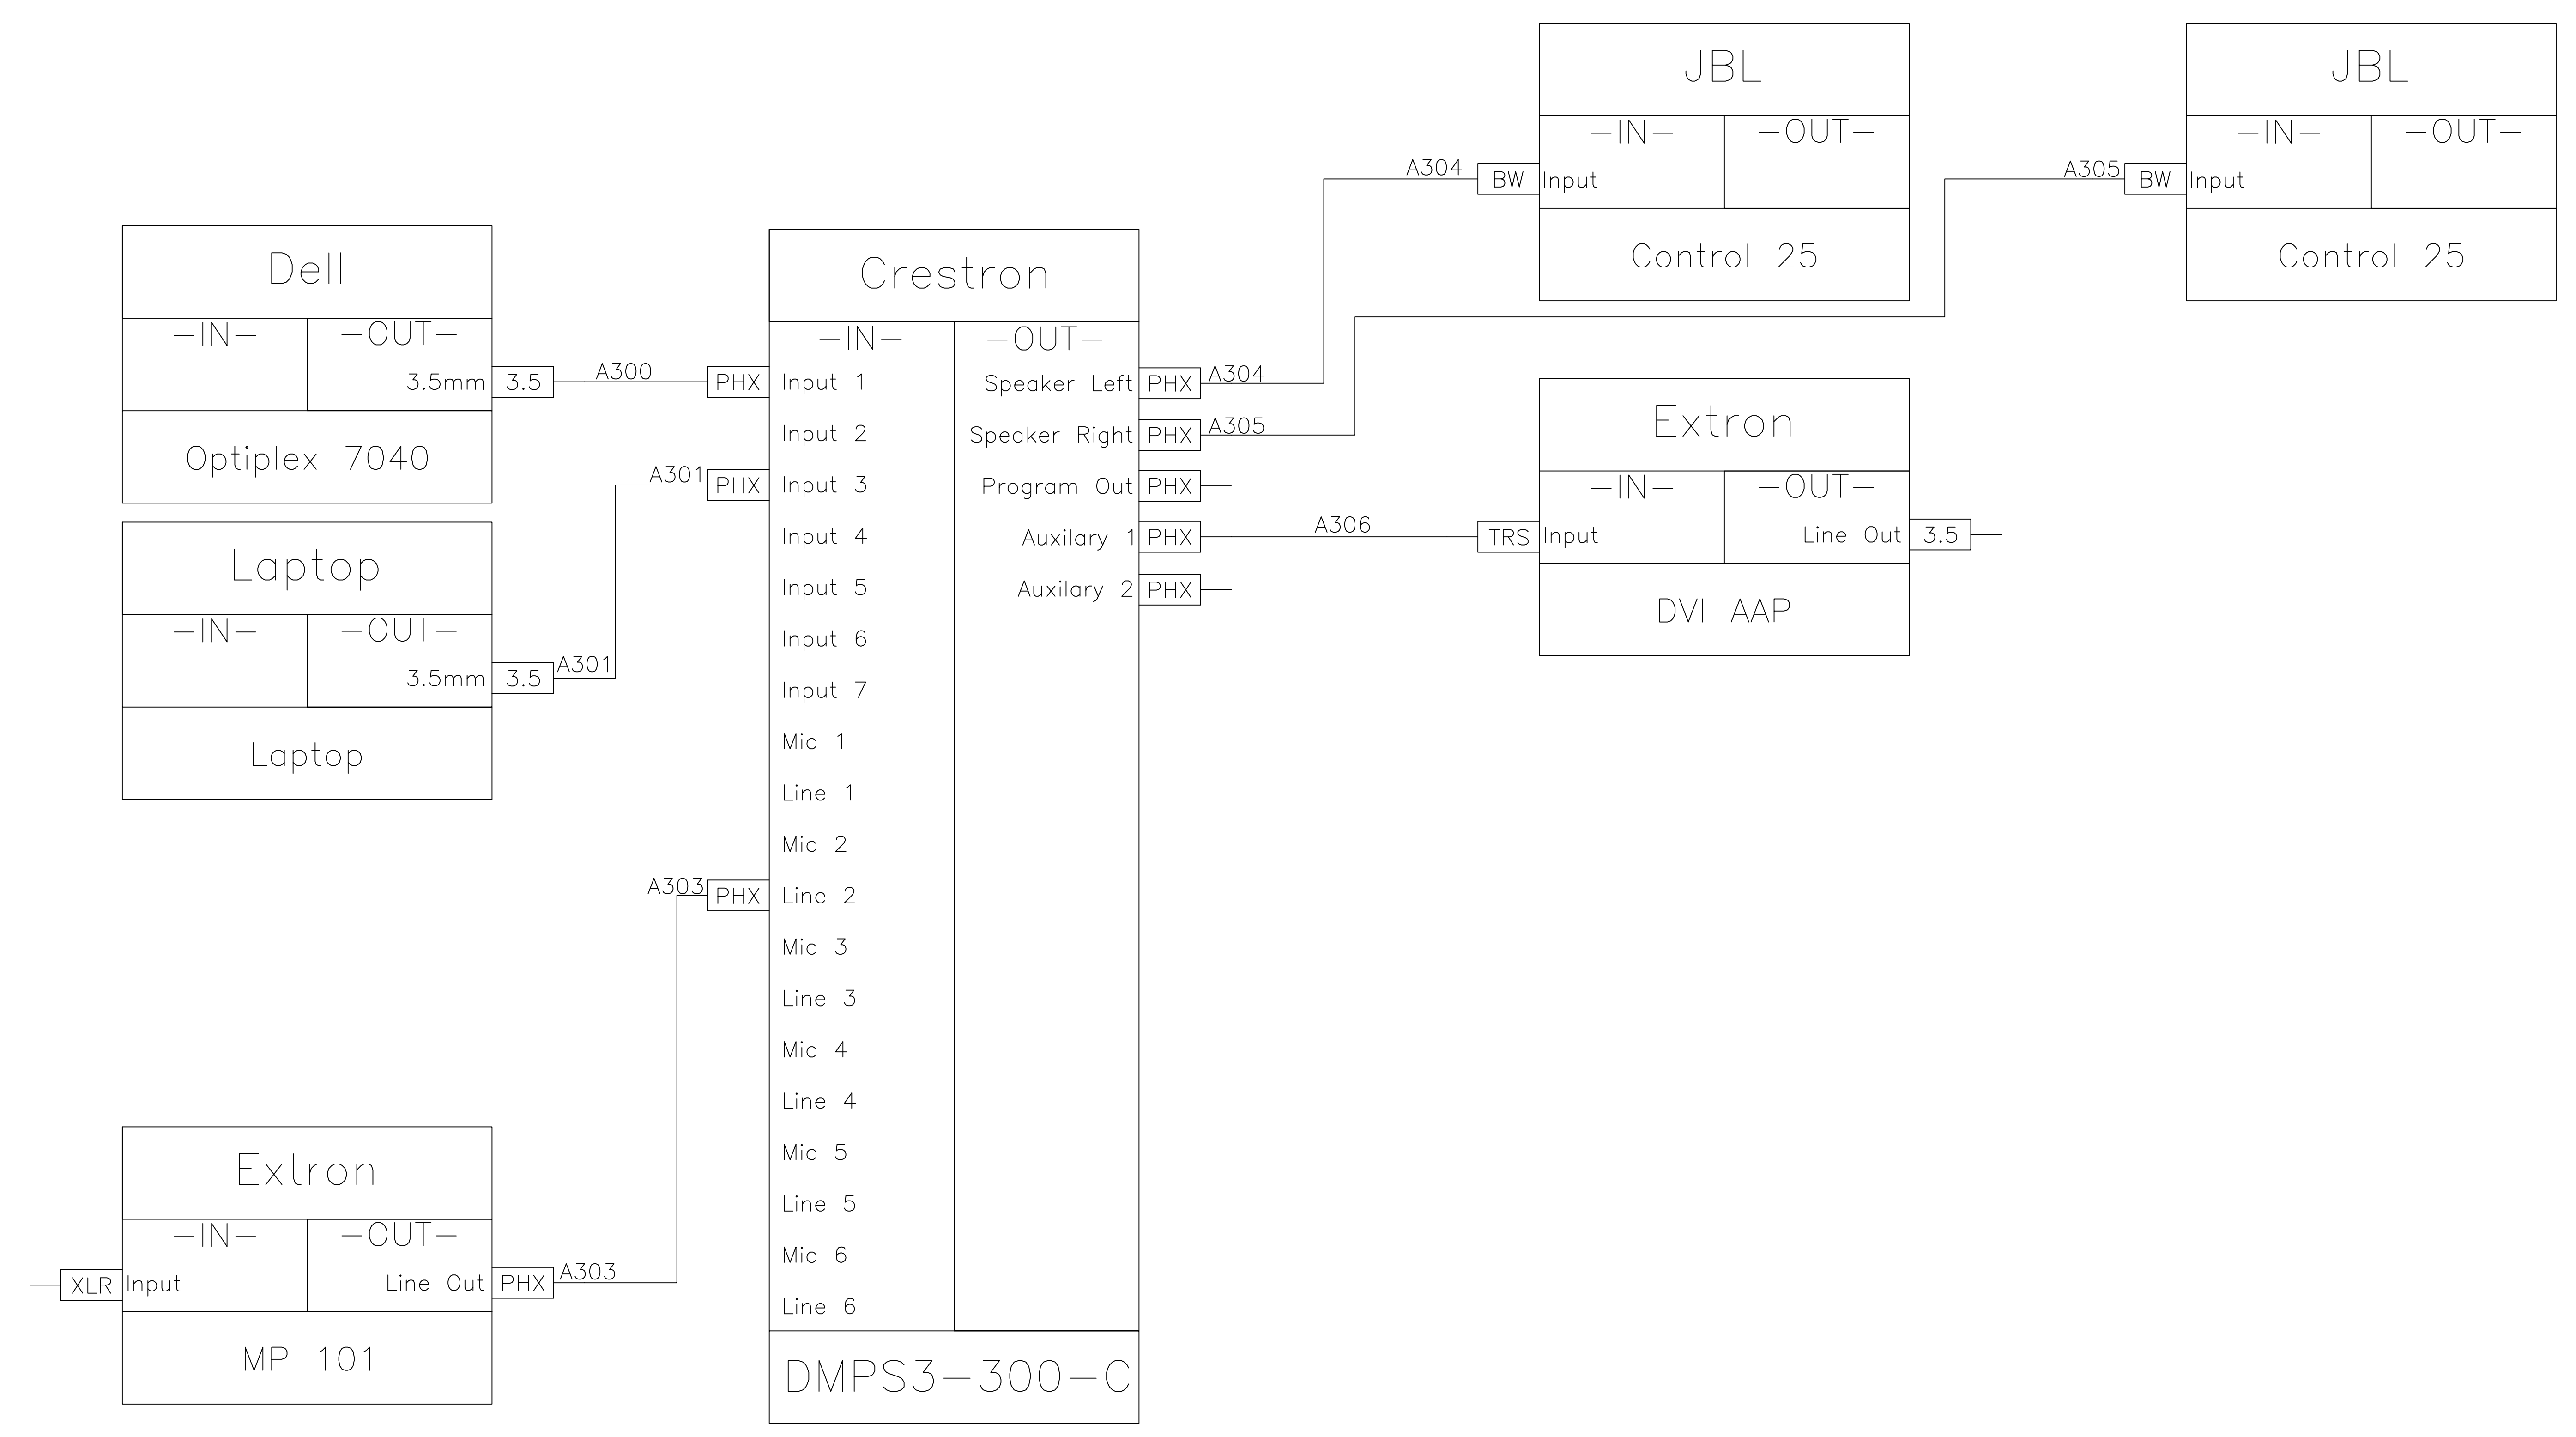

1 AUDIOVISUAL AUDIO FLOW
 402 NO SCALE


REV.	DATE	APPROV.	STATUS	DESCRIPTION
1				
2				
3				
4				
5				
6				
7				
8				
9				
10				

Project: NORTH CAROLINA STATE UNIVERSITY
 CLASSTECH STANDARD
 Drawing Title: SINGLE LINE DIAGRAMS
 AUDIO, VIDEO, CONTROL, NETWORK

Scale: NONE
 Date: 2017-2018
 Drawn by: BRENNAN WATSON
 Checked by:

Project Number:

Drawing #
 AV-402

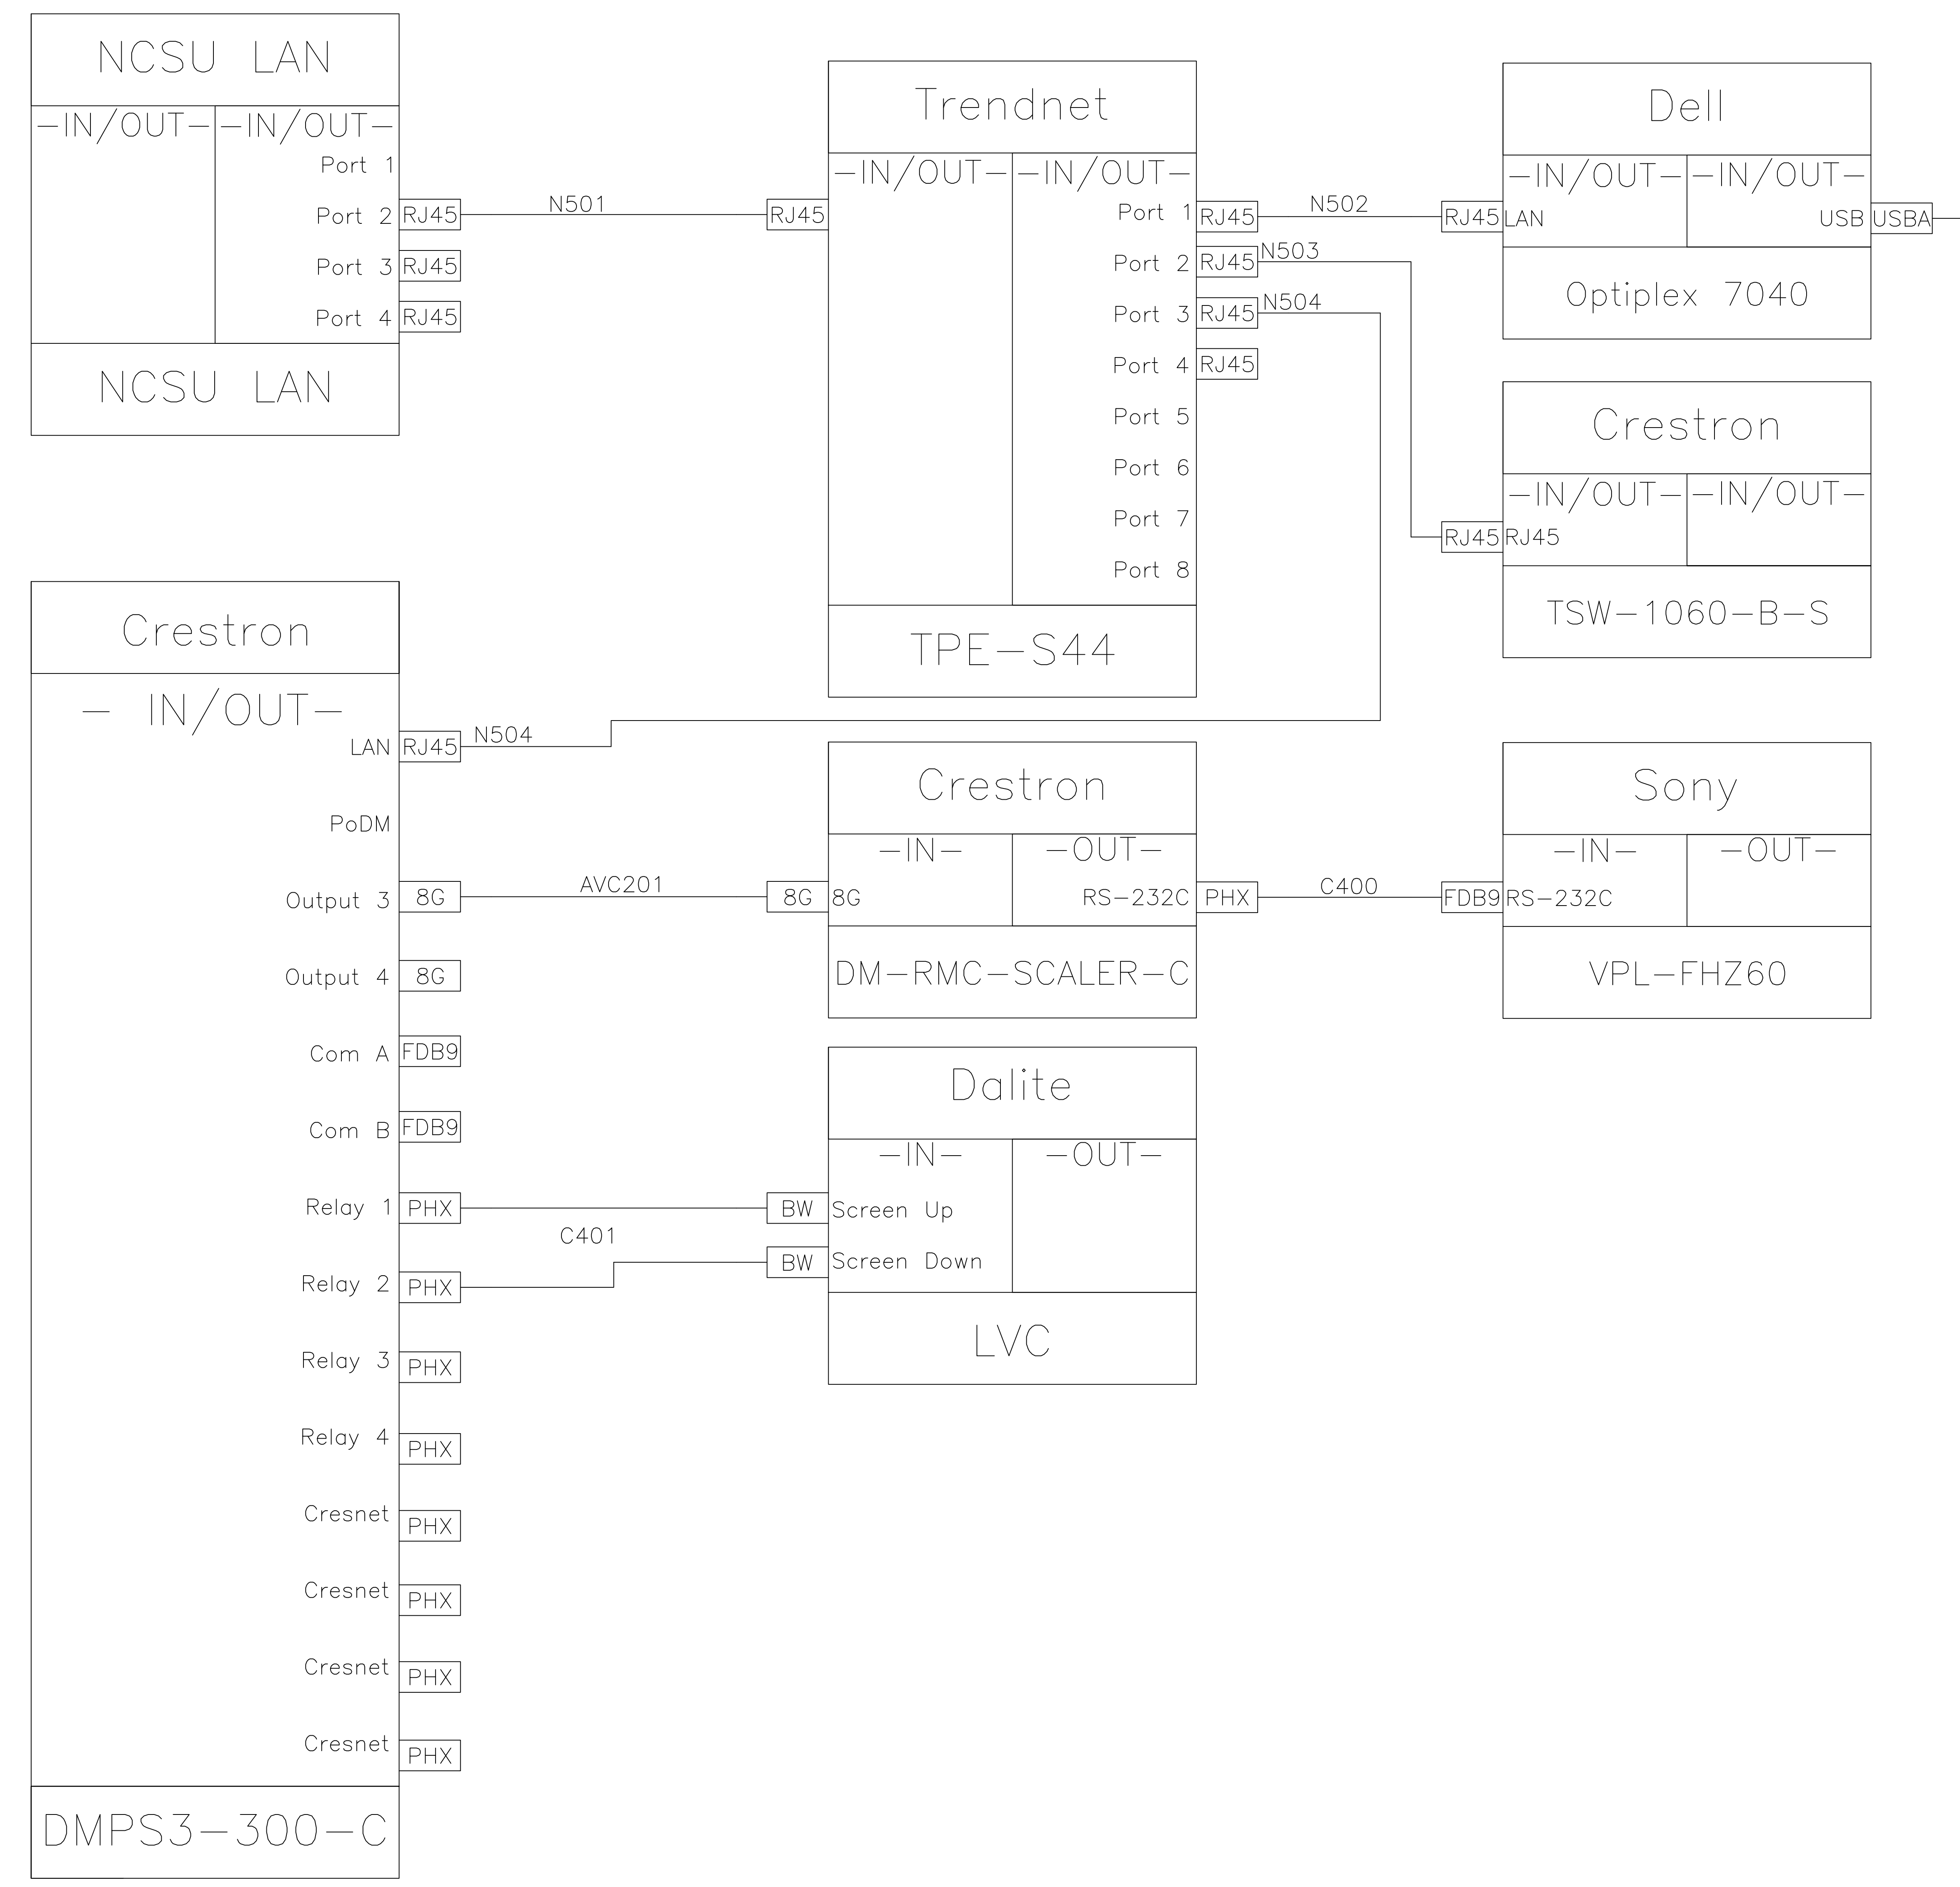

1 AUDIOVISUAL CONTROL FLOW
 403 NO SCALE

REV.	DATE	APPROV.	STATUS	DESCRIPTION
1				
2				
3				
4				
5				
6				
7				
8				
9				
10				

Project: NORTH CAROLINA STATE UNIVERSITY
 CLASSTECH STANDARD
 Drawing Title: SINGLE LINE DIAGRAMS
 AUDIO, VIDEO, CONTROL, NETWORK

Scale: NONE
 Date: 2017-2018
 Drawn by: BRENNAN WATSON
 Checked by:

Project Number:

Drawing # AV-403